

Luminaire Schedule							
Symbol	Qty	Label	Arrangement	LLF	Description	Arr. Watts	Lum. Lumens
	1	AA42	Twin	0.900	GARDCO ECF-S-48L-1 2A-NW-G2-4WITH ROTATED OPTICS MOUNT ON 20FT POLE WITH 2FT BASE	365.42	23179
	2	AA2	Single	0.900	GARDCO ECF-S-48L-1 2A-NW-G2-2 MOUNT ON 20FT POLE WITH 2FT BASE	182.71	22647
	3	AA4H	Single	0.900	GARDCO ECF-S-48L-1 2A-NW-G2-4-HIS MOUNT ON 20FT POLE WITH 2FT BASE	182.71	18176
	2	AA4H2	Twin	0.900	GARDCO ECF-S-48L-1 2A-NW-G2-4-HIS WITH ROTATED OPTICS MOUNT ON 20FT POLE WITH 2FT BASE	365.42	18176
	2	AA52	Back-Back	0.900	GARDCO ECF-S-48L-1 2A-NW-G2-5W MOUNT ON 20FT POLE WITH 2FT BASE	365.42	23040
	5	WP1	Single	0.900	STONCO PW15-NW-G1-8 WALL MOUNT AT 8FT	15	1656
	2	WP2	Single	0.900	STONCO PW50-NW-G1-8 WALL MOUNT AT APPROX 12FT	50.9	5114


Calculation Summary							
Label	CalcType	Units	Avg	Max	Min	Avg/Min	Max/Min
SITE GROUND	Illuminance	Fc	1.27	9.2	0.0	N.A.	N.A.
EAST PARKING	Illuminance	Fc	2.30	3.6	1.1	2.09	3.27
WEST PARKING	Illuminance	Fc	2.93	8.6	1.3	2.25	6.62



TYPE AA



TYPE WP

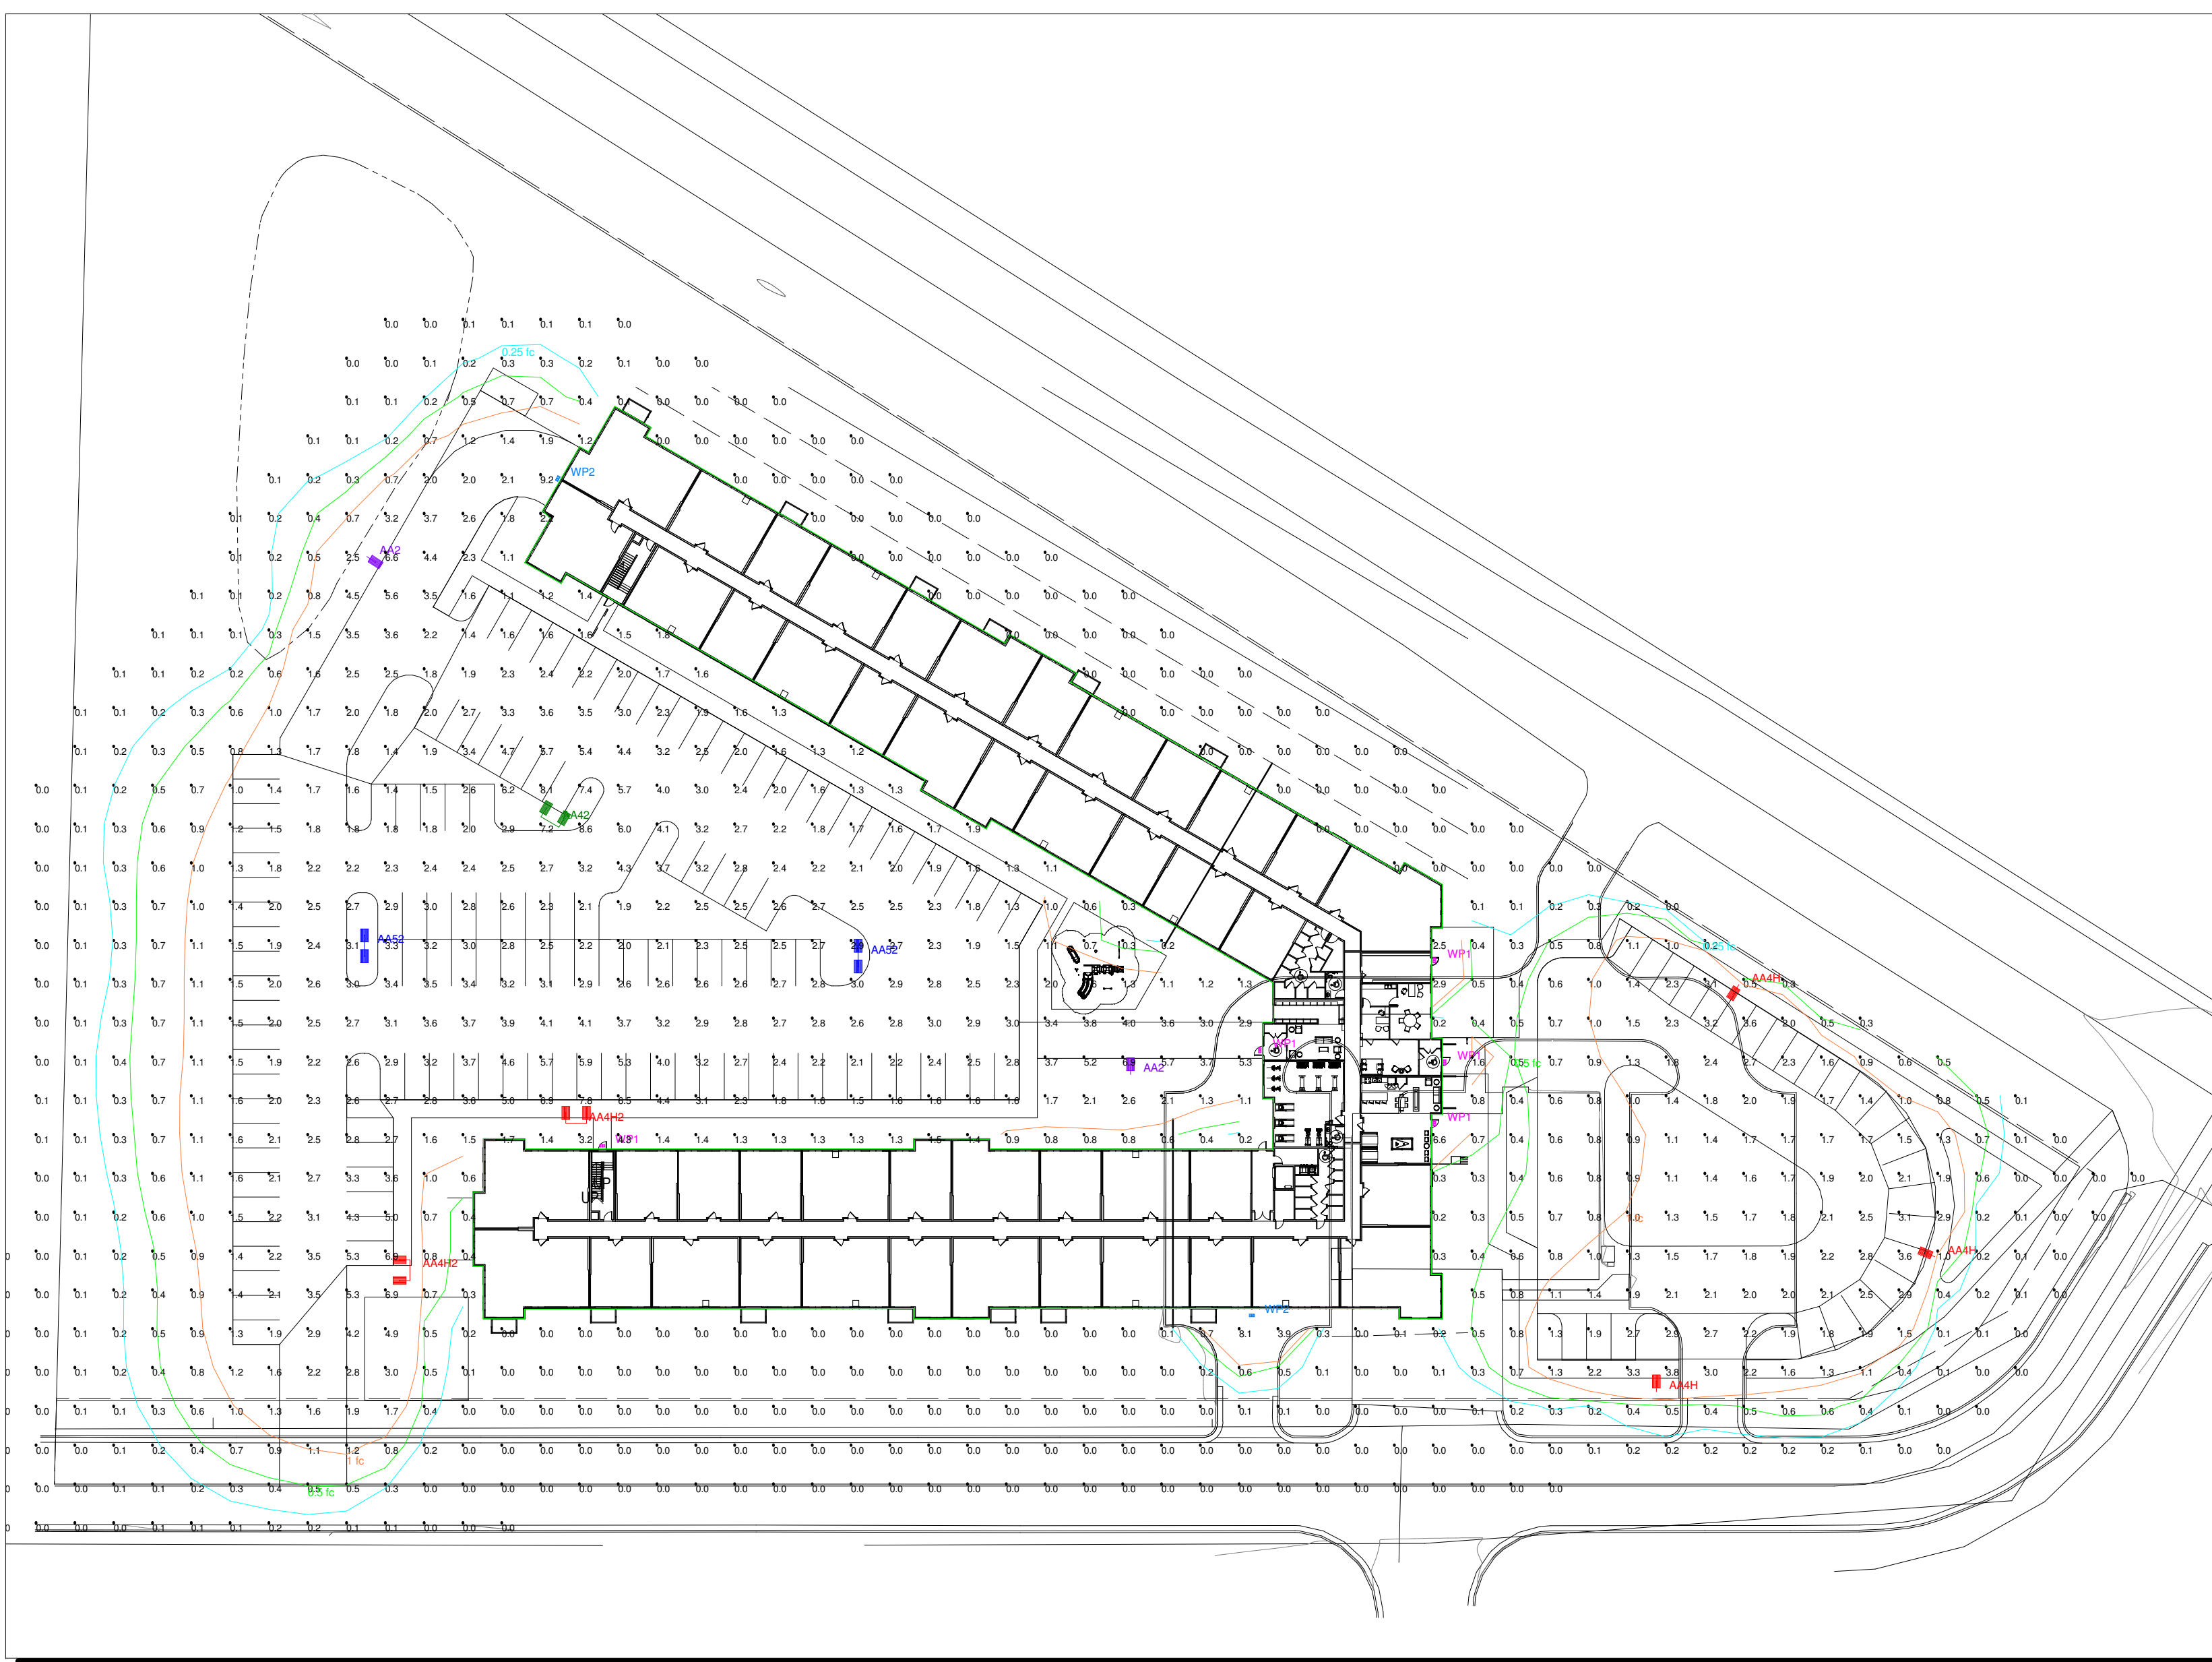

Plan View  
Scale: 1 inch = 50 Ft.

**GENERAL NOTES:**

A. PULSE PRODUCTS DOES NOT ASSUME RESPONSIBILITY FOR THE INTERPRETATION OF THIS CALCULATION OR COMPLIANCE TO THE LOCAL, STATE, OR FEDERAL LIGHTING CODES OR ORDINANCES.

B. LIGHTING LAYOUT IS NOT INTENDED FOR CONSTRUCTION DOCUMENTS BUT ONLY TO ILLUSTRATE THE PERFORMANCE OF THE PRODUCT.

C. ALL READINGS/CALCULATIONS SHOWN ARE SHOWN ON OBJECTS/SURFACES.



#	Date	Comments

Revisions

Drawn By: SANDY  
Checked By: ROSS  
Date: 8/5/2021

Scale: AS NOTED

**REAL ESTATE EQUITIES**  
**MAPLEWOOD, MN**